


FILE LOCATION: E:\DRAWINGS\SENECA CONSTRUCTION\KUM & GO\521 - CORALVILLE, IA\521 - CORALVILLE, IA

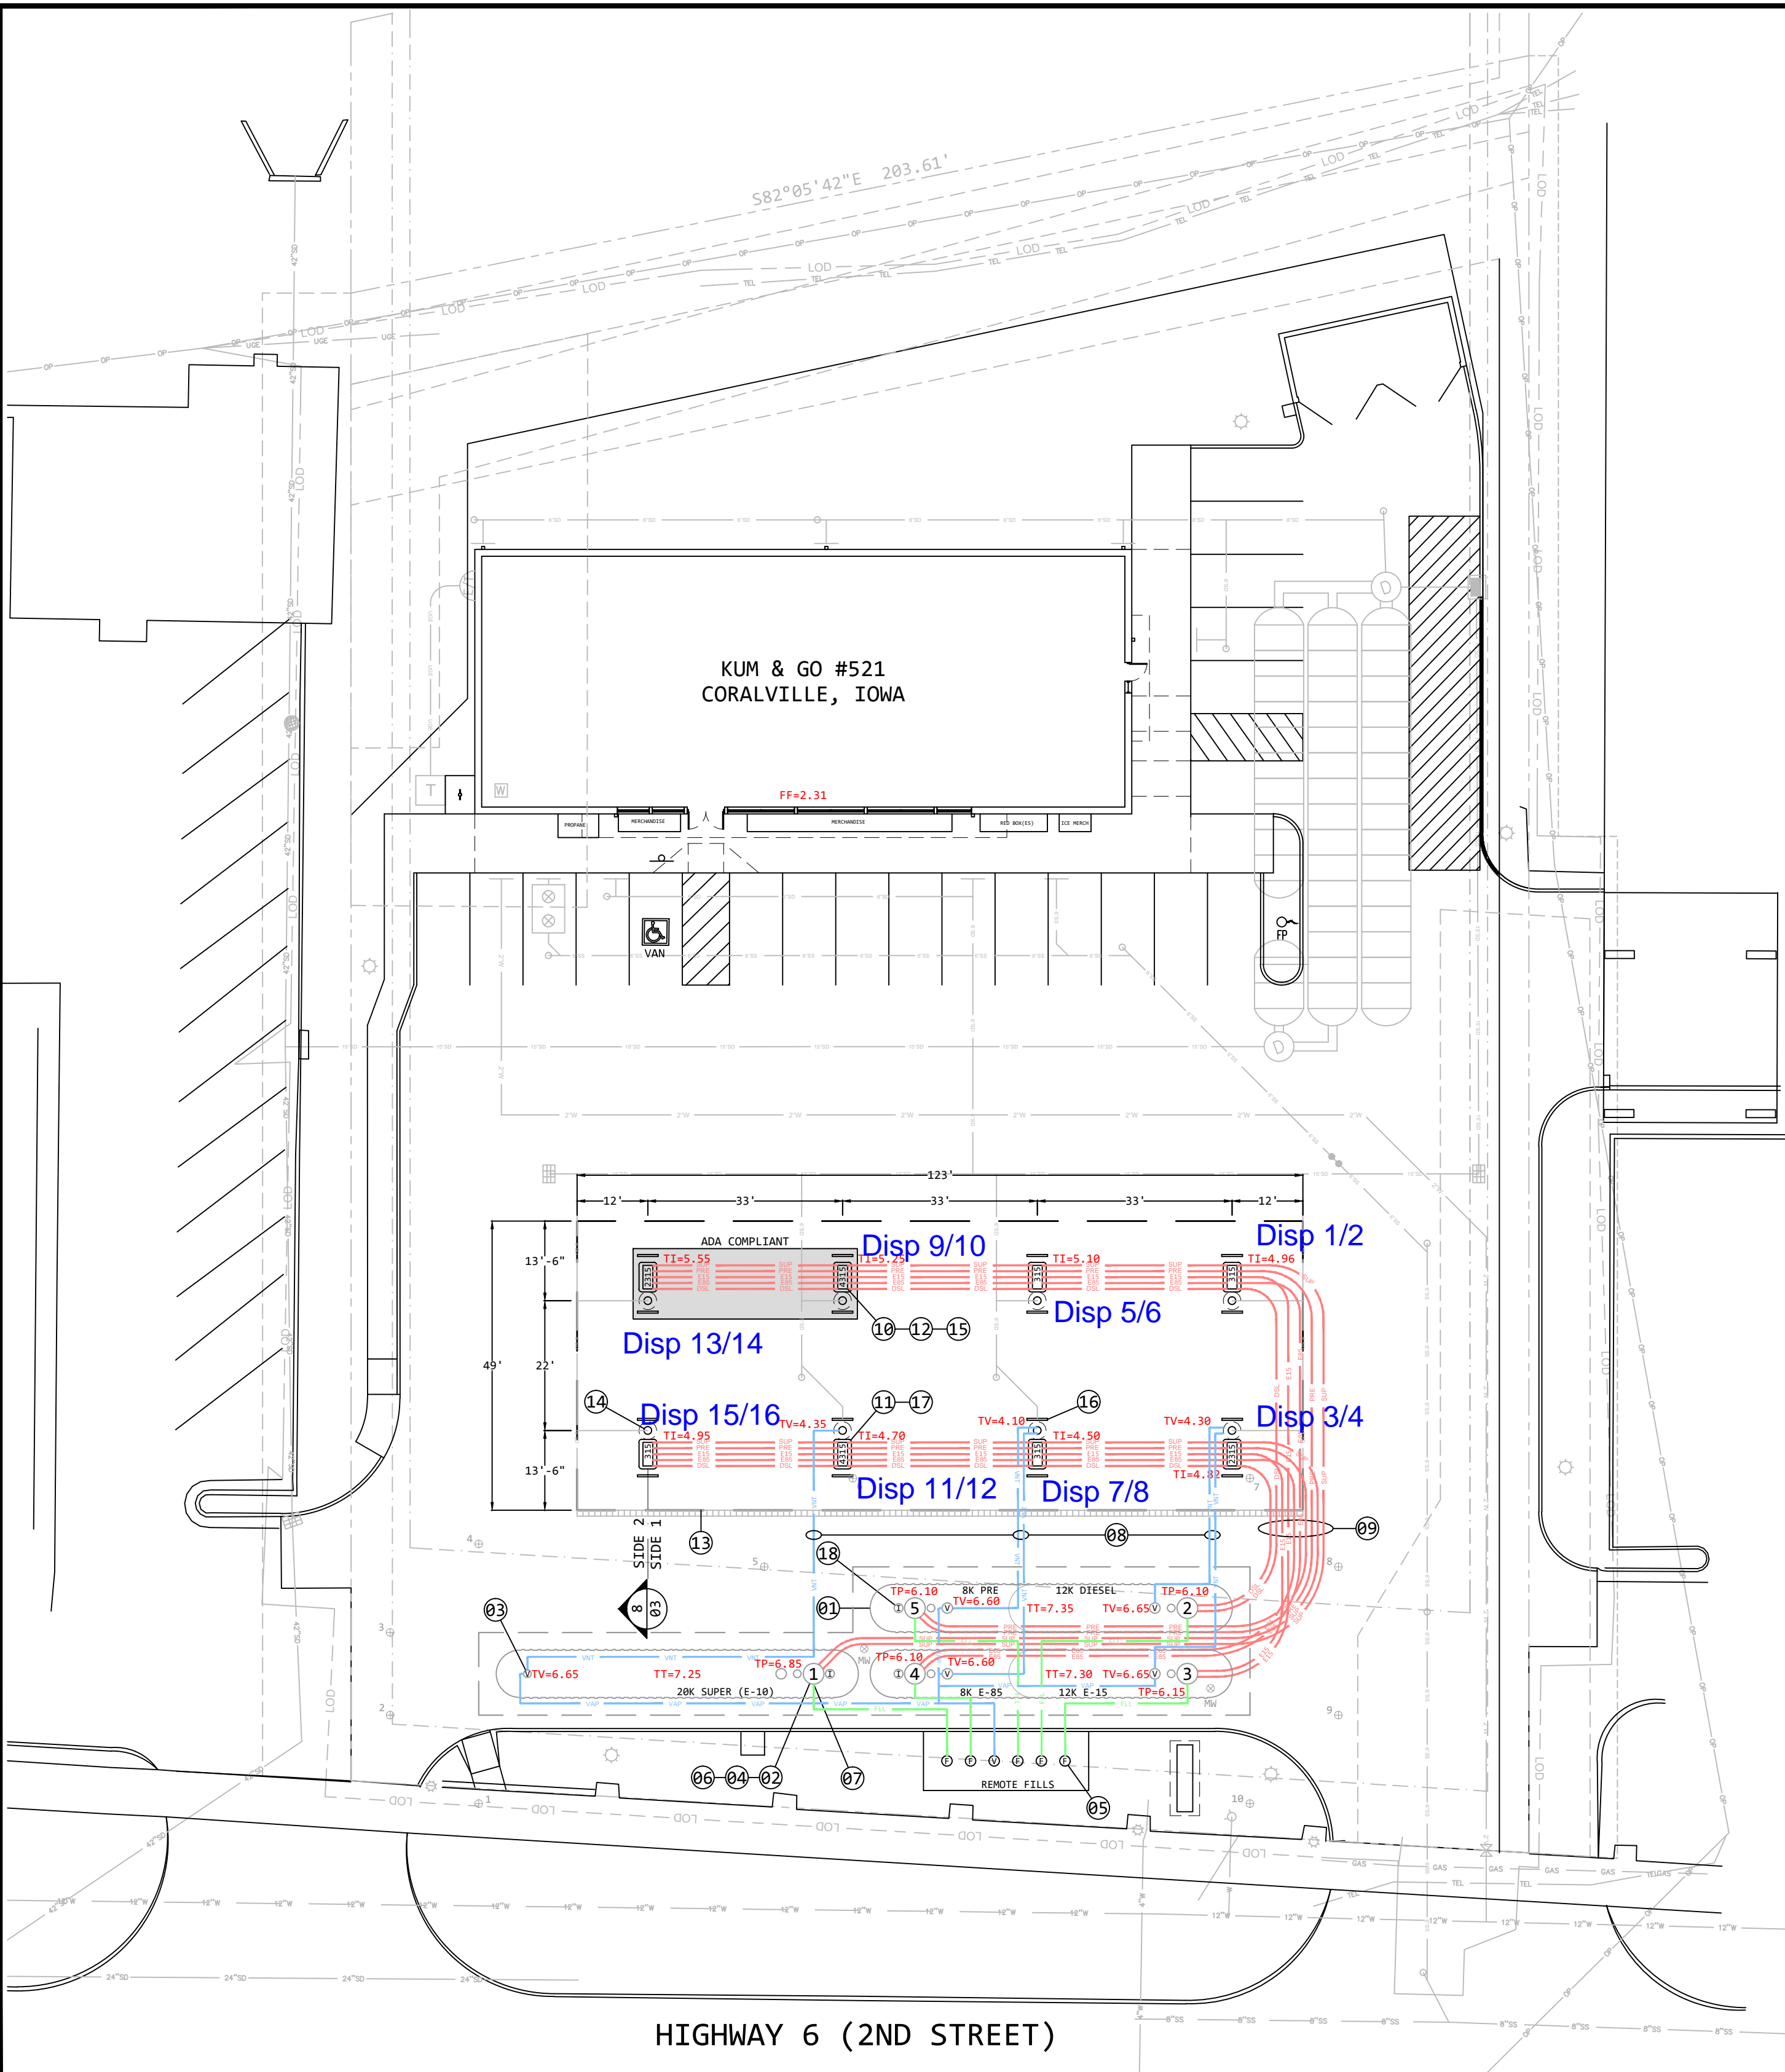


KEYNOTES	
01	UST - ONE 20K, TWO 20K SPLIT (12K,8K) ; FIBERGLASS
02	PIPING SUMP - TYPICAL OF FIVE
03	VENT CONNECTION - TYPICAL OF FIVE
04	STP W/LEAK DETECTOR - TYPICAL OF FIVE
05	SPILL CONTAINMENT MANHOLE (FILL) - TYPICAL OF FIVE
06	TANK MONITOR PROBE - TYPICAL OF FIVE
07	OVERFILL VALVE - TYPICAL OF FIVE
08	VENT PIPING (2" FIBERGLASS) - AS SHOWN
09	PRODUCT PIPING (APT) - AS SHOWN
10	DISPENSER SUMP - TYPICAL OF EIGHT
11	ISLAND FORM - TYPICAL OF EIGHT - 3' x 5'
12	DISPENSING UNIT - TYPICAL OF EIGHT
13	CANOPY - 49' x 123'
14	CANOPY COLUMN - TYPICAL OF EIGHT
15	EMERGENCY VALVE - TYPICAL OF TWENTY-EIGHT
16	42" U-SHAPED BUMPER GUARD - TYPICAL OF SIXTEEN
17	TEES & PLUGS TO BE UTILIZED IN DISPENSER SUMPS FOR UNTAPPED PRODUCT PIPING
18	INTERSTITIAL

**PRODUCT LEGEND:**

 - 1-MID-GRADE
- 2-DIESEL
- 3-E15
- 4-E85
- 5-PREMIUM
- 6-UNLEADED
- 7-DEF

**PIPING LEGEND:(LABELS)**

- DIEL DIESEL
- E15 E-15
- E85 E-85
- FILL FILL
- PREM PREMIUM
- SUPR SUPER (E-10)
- VENT VENT
- VAPR VAPOR



HIGHWAY 6 (2ND STREET)

ASBUILT

REVISION DATE:	BY:
04/15/2015	DW
07/06/2015	AM
07/08/2015	DW
07/10/2015	AM
07/17/2015	AM
09/24/2015	DW

THIS DRAWING AND ALL PARTS THEREOF IS THE EXCLUSIVE PROPERTY OF SENECA COMPANIES AND MAY NOT BE REPRODUCED IN WHOLE OR PART WITHOUT WRITTEN PERMISSION.

The Complete Solution

KUM & GO #521 CORALVILLE, IOWA	
SCALED SITE PLAN	
DATE DRAWN:	03/17/2015
DRAWN BY:	DARRICK WORRALL
CHECKED BY:	AARON MILLER
SCALE:	1"=20'
PROJECT NO:	ASBUILT
SHEET NO.	01